



REBUILDING TO BE CONNECTED TO  
EXISTING TRUNK MAIN


ACCESS TO BUILDING SITE TO BE LIMITED  
AS DIRECTED BY CITY ENGINEER

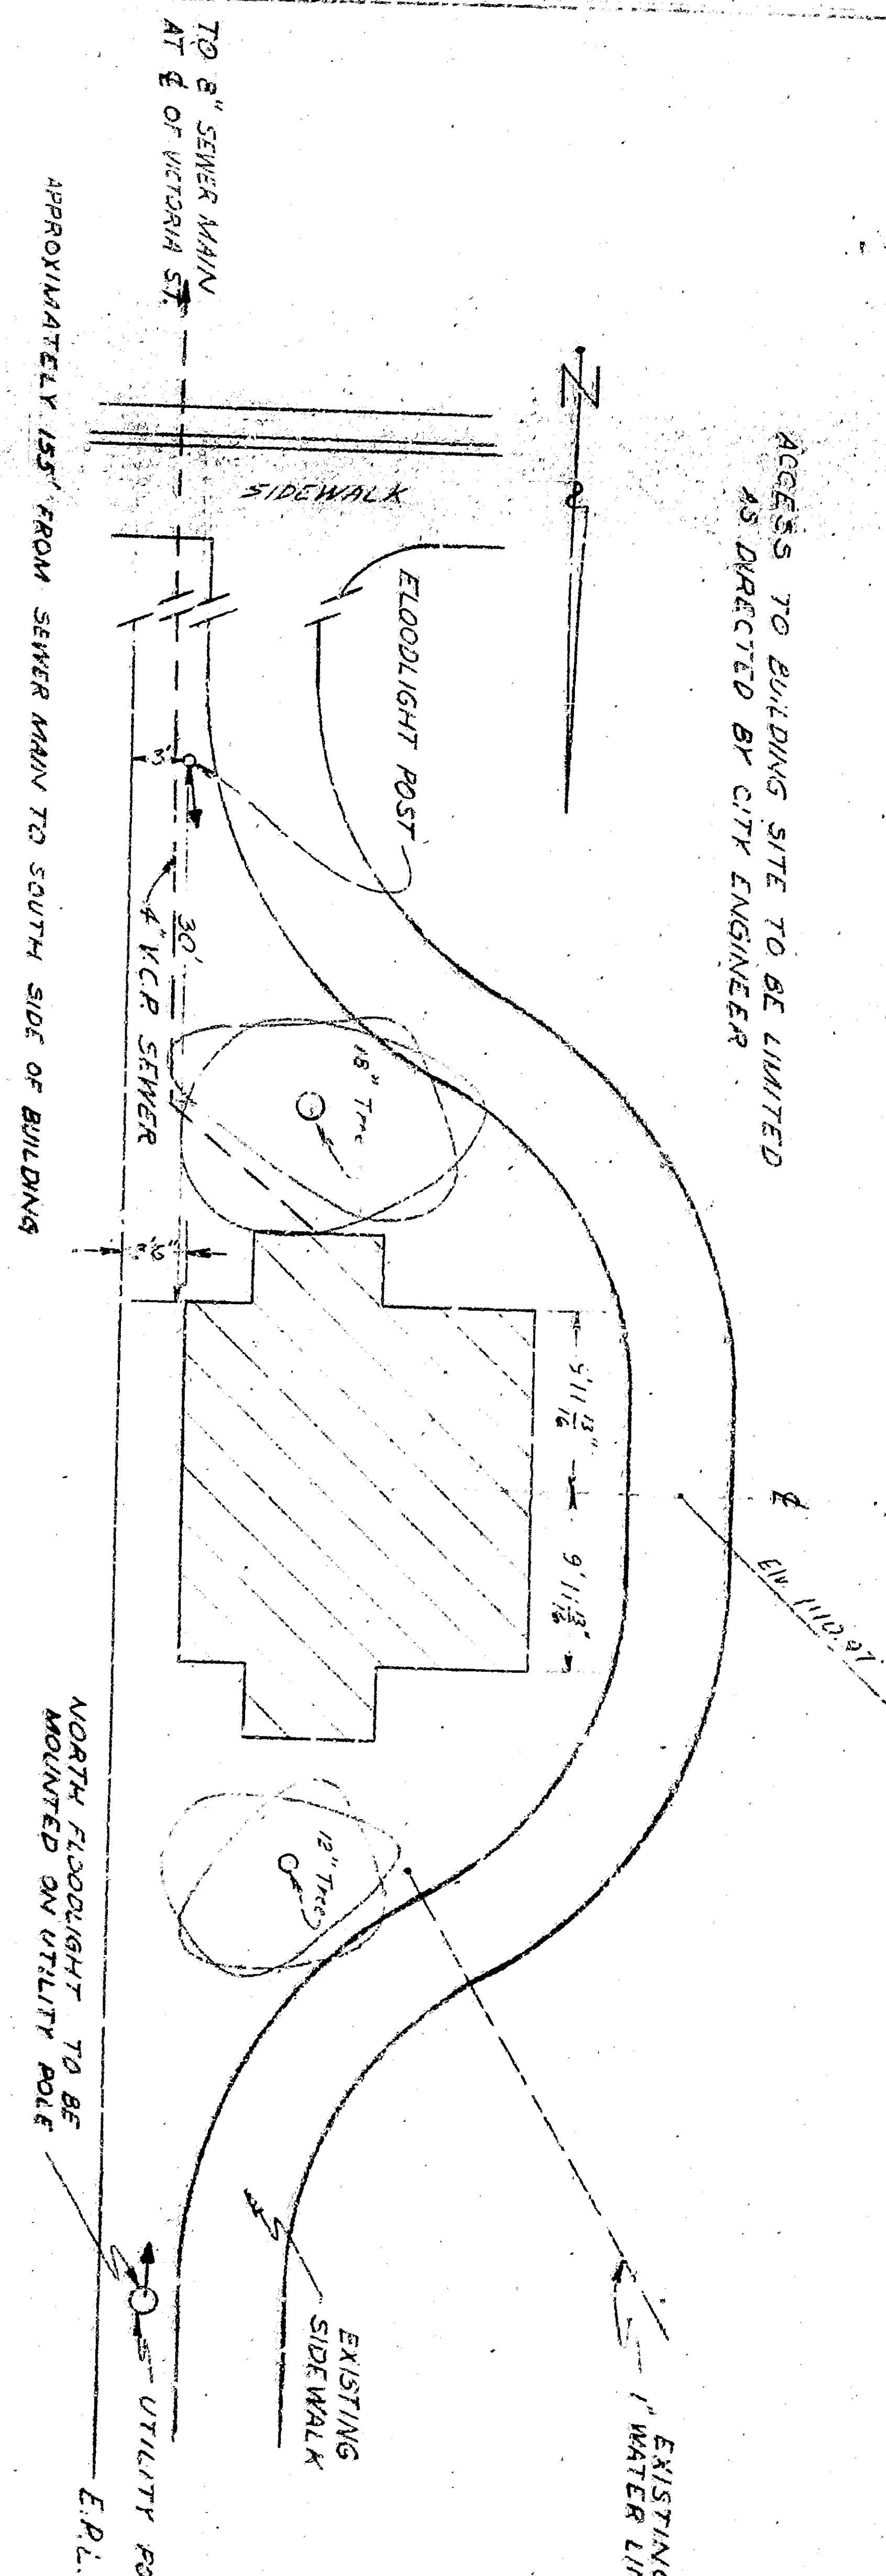


PLOT PLAN  
SCALE: 1/8" = 1'-0"

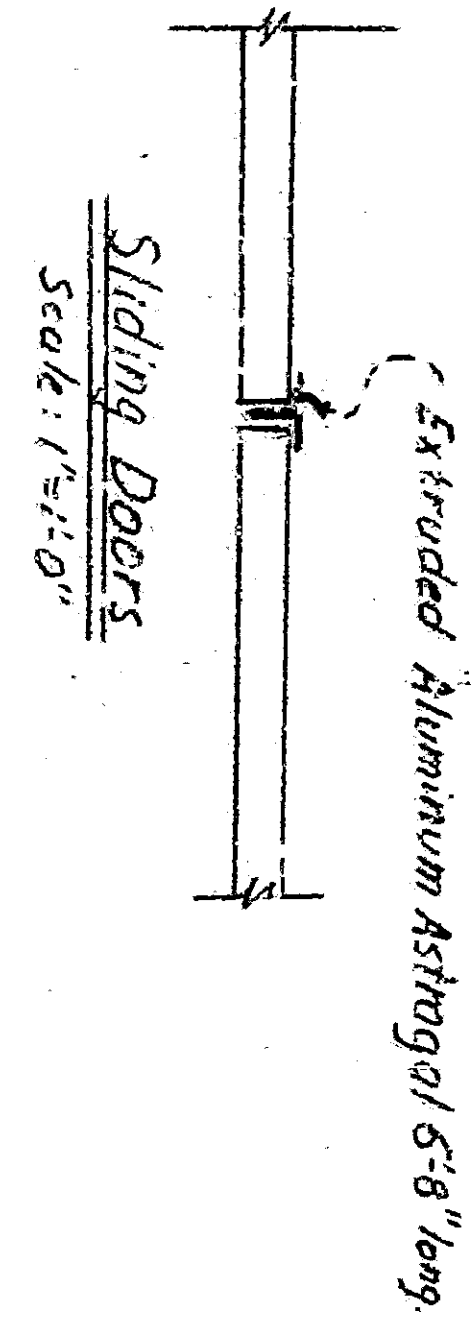

Sliding Door  
Scale: 1/8" = 1'-0"

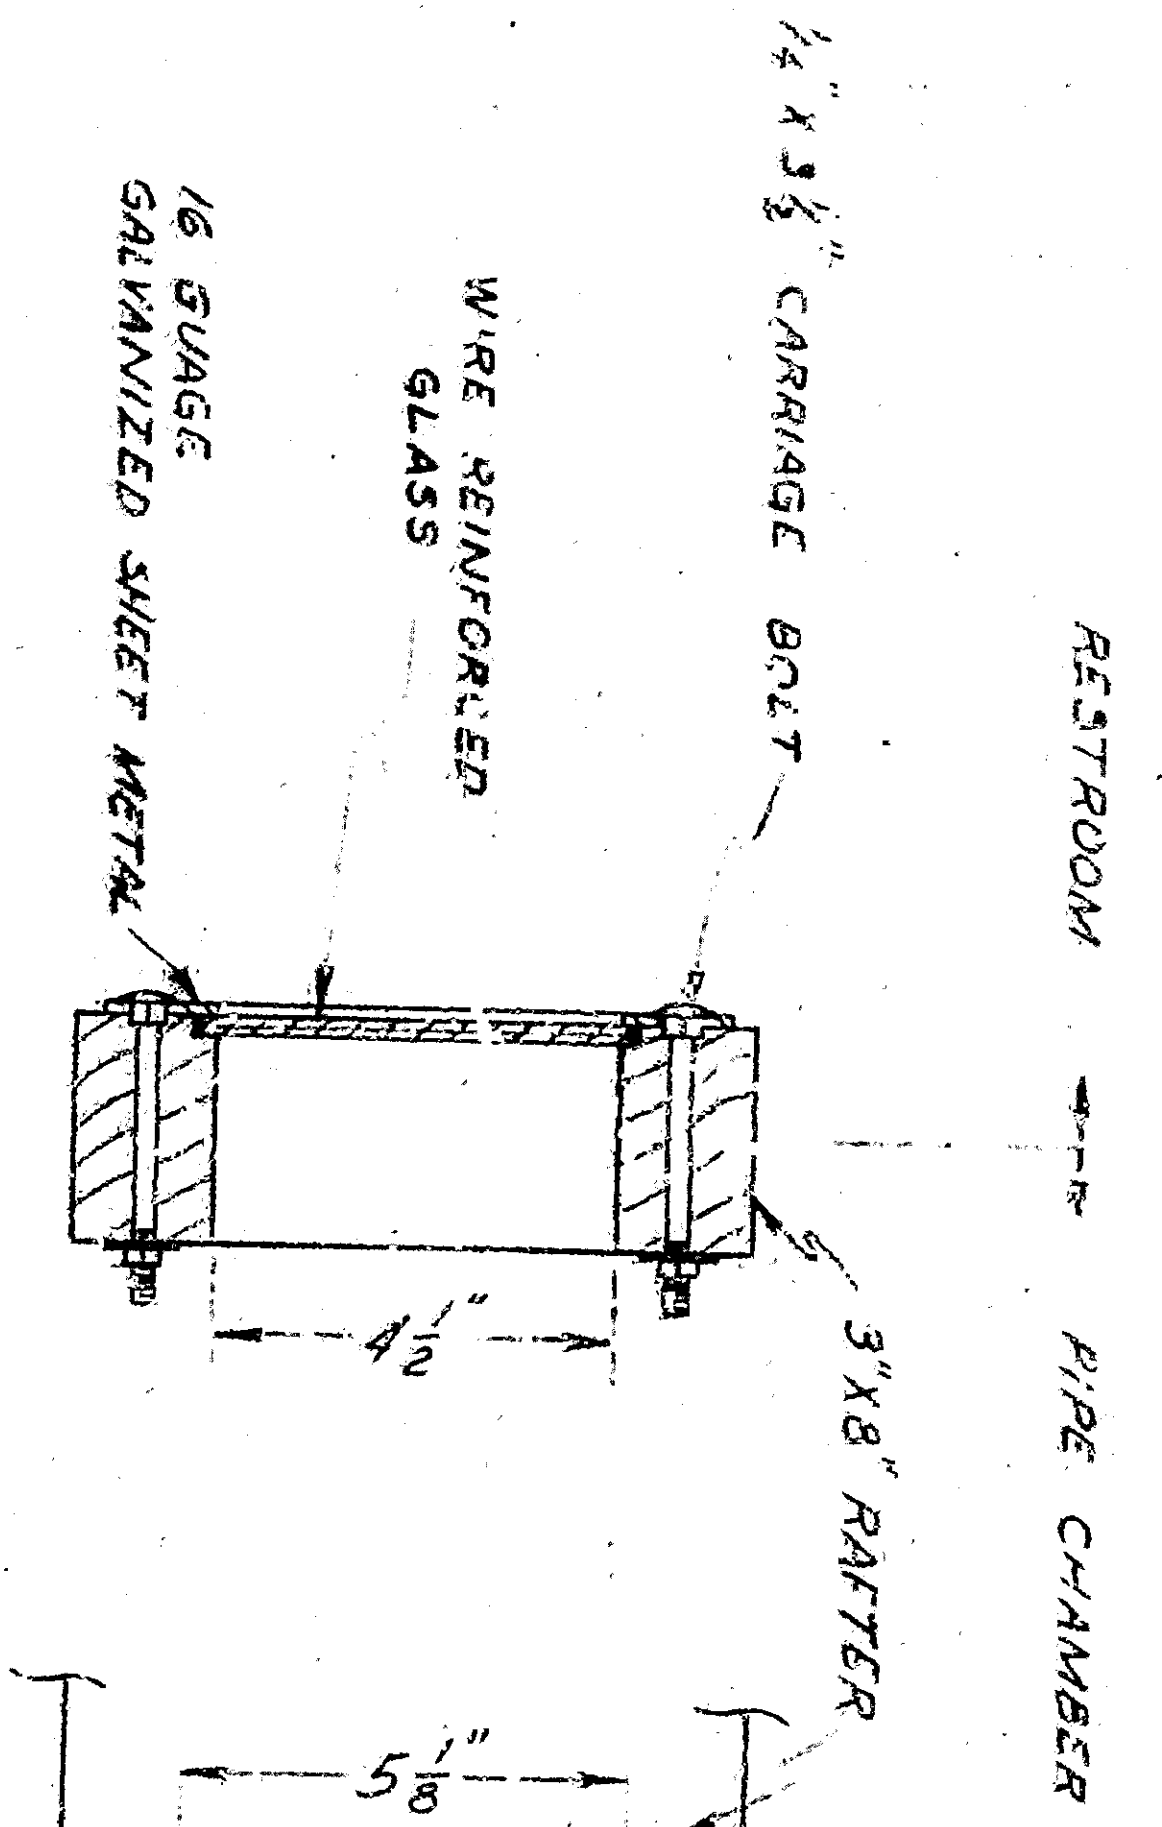


RESTROOM  
PIPE CHAMBER

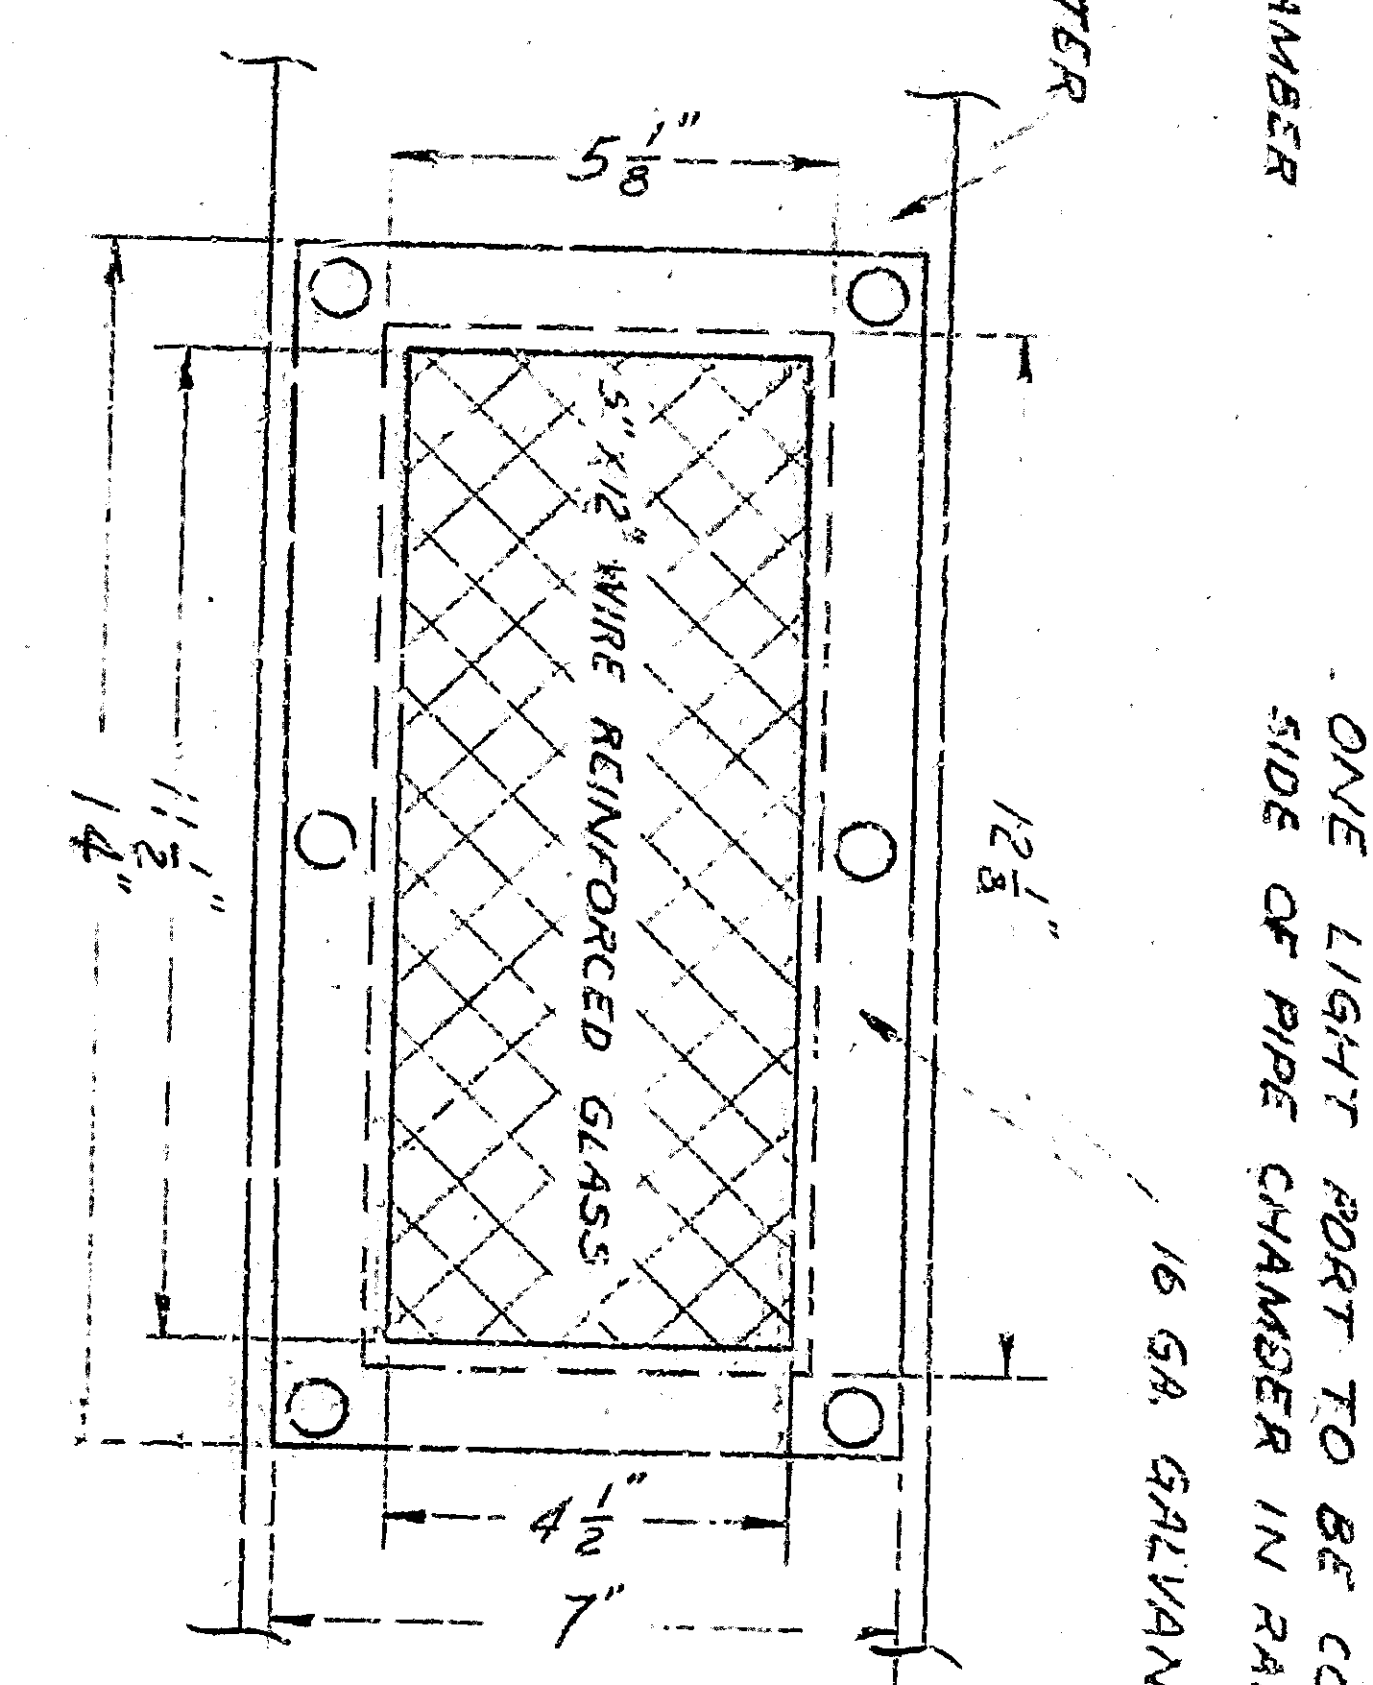

LIGHT PORT - DETAIL  
SCALE: 1/8" = 4"


ONE LIGHT PORT TO BE CONSTRUCTED ON EACH  
SIDE OF PIPE CHAMBER IN RAFTER ALONGSIDE CEILING LIGHT  
1/8 GA GALVANIZED SHEET METAL

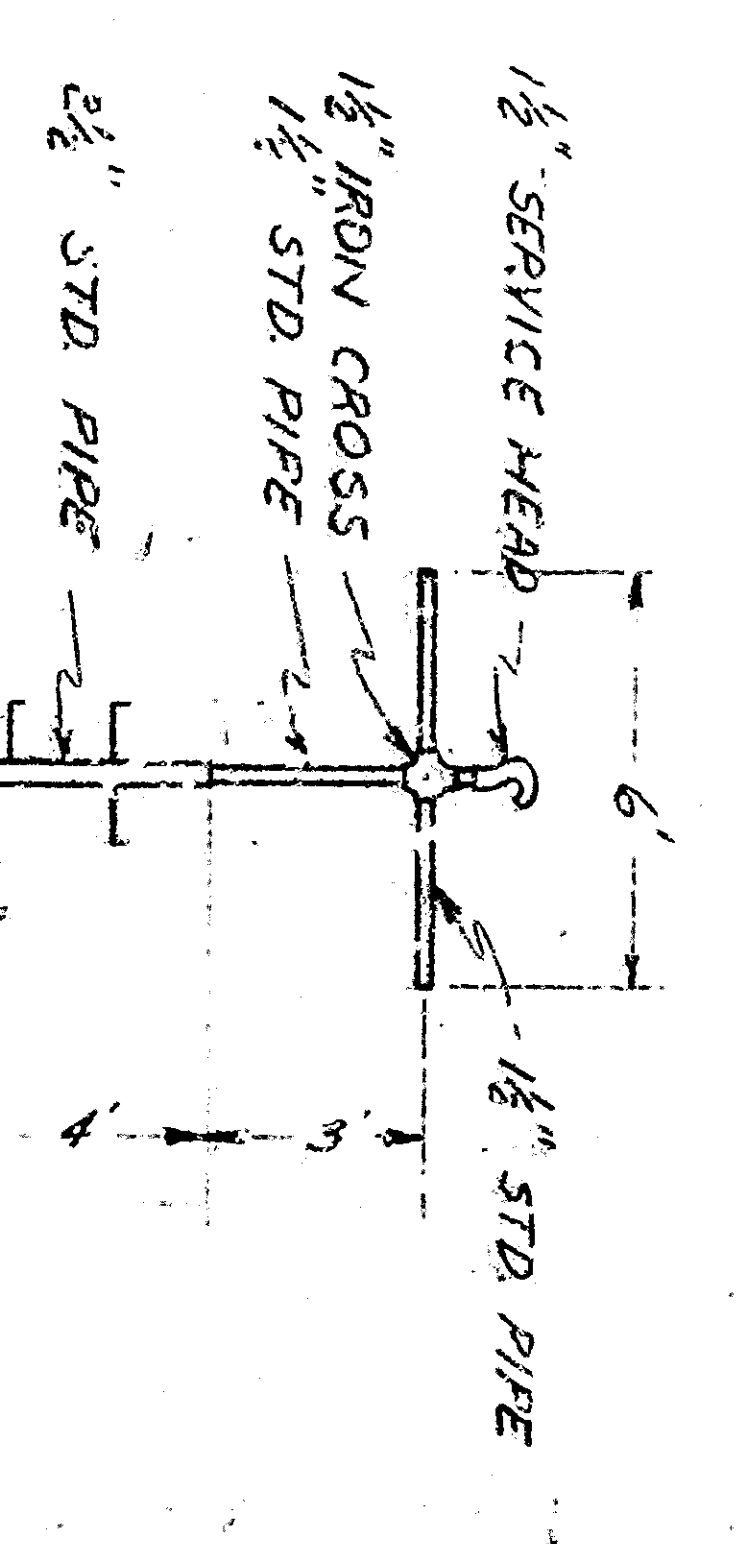


FLOODLIGHT POST - DETAIL  
NO SCALE

DOOR SCHEDULE


(A)	2'-3" 0" x 6'-8" 1/4"
(B)	3'-0" 1" x 6'-8" 1/4"
(D)	2'-4" 0" x 7'-8" 1/8"

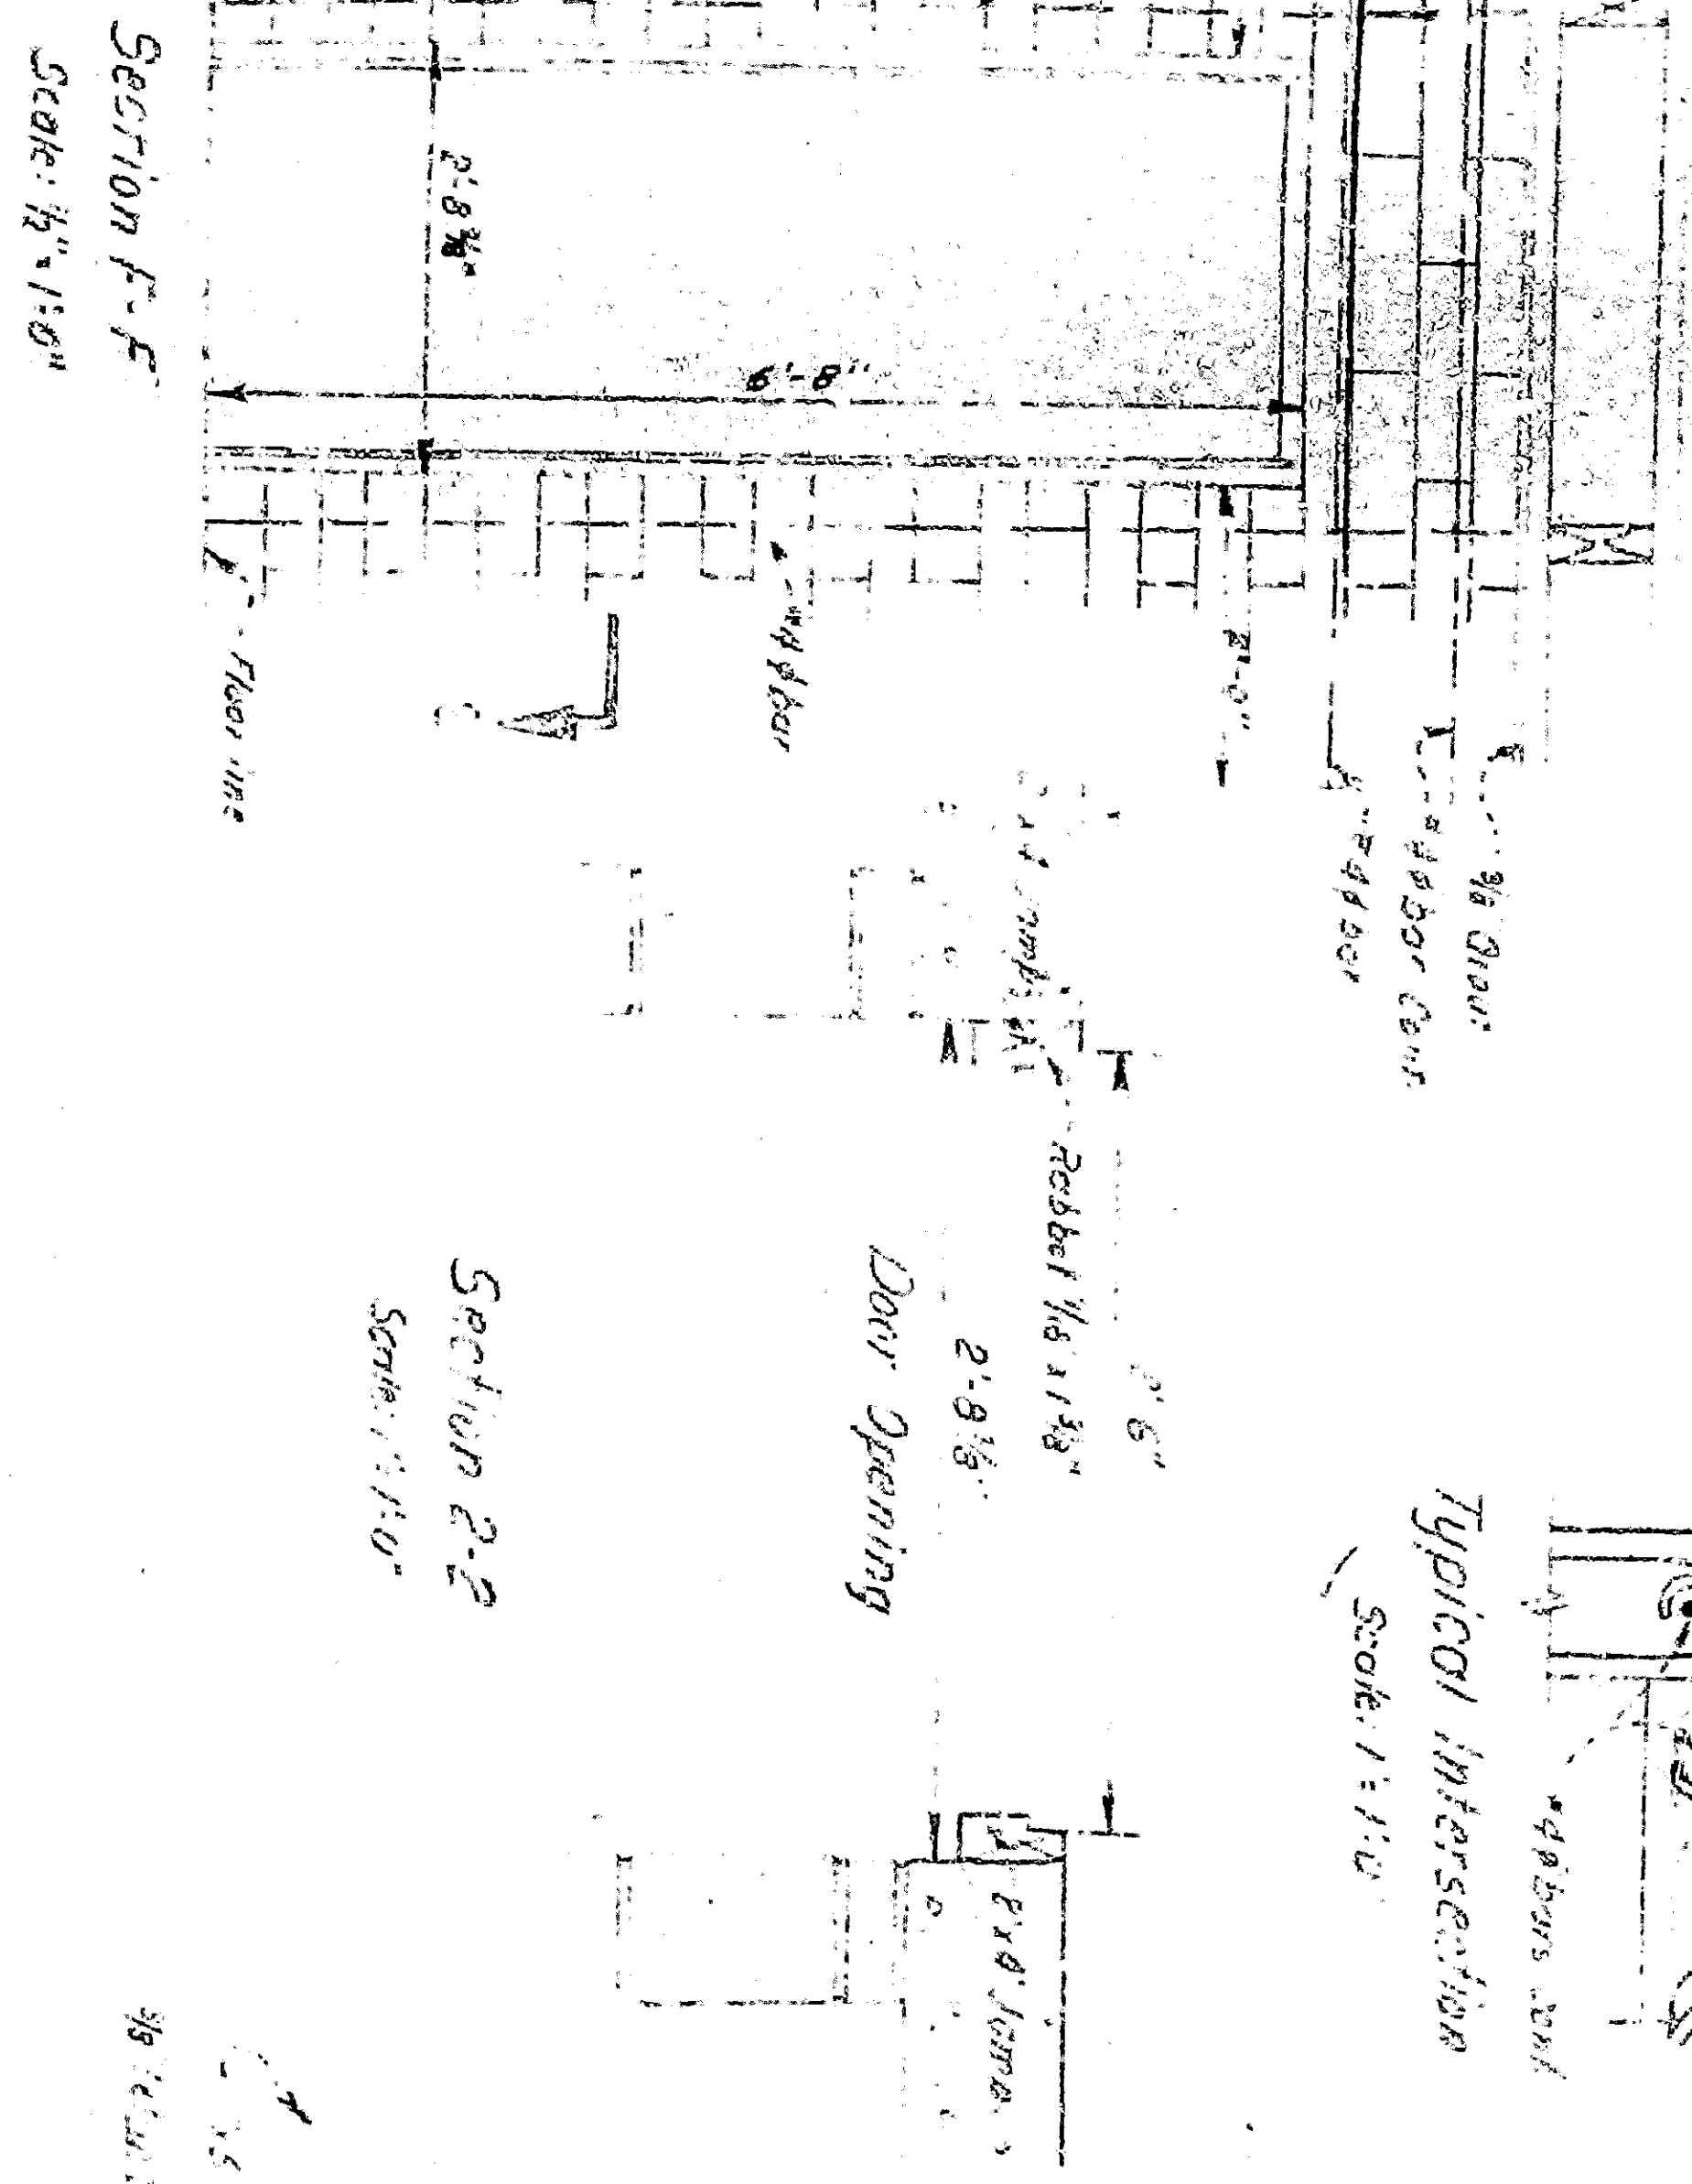

Section F-F  
Scale: 3/16" = 1'-0"

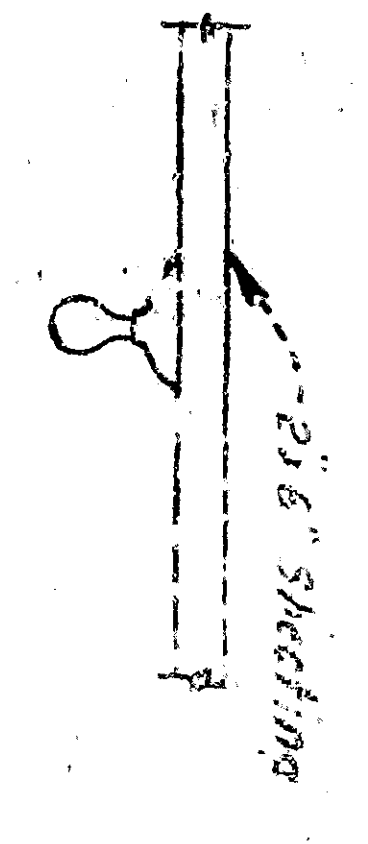

Lighting Details - PIPE CHAMBER  
Scale: 1/8" = 1'-0"

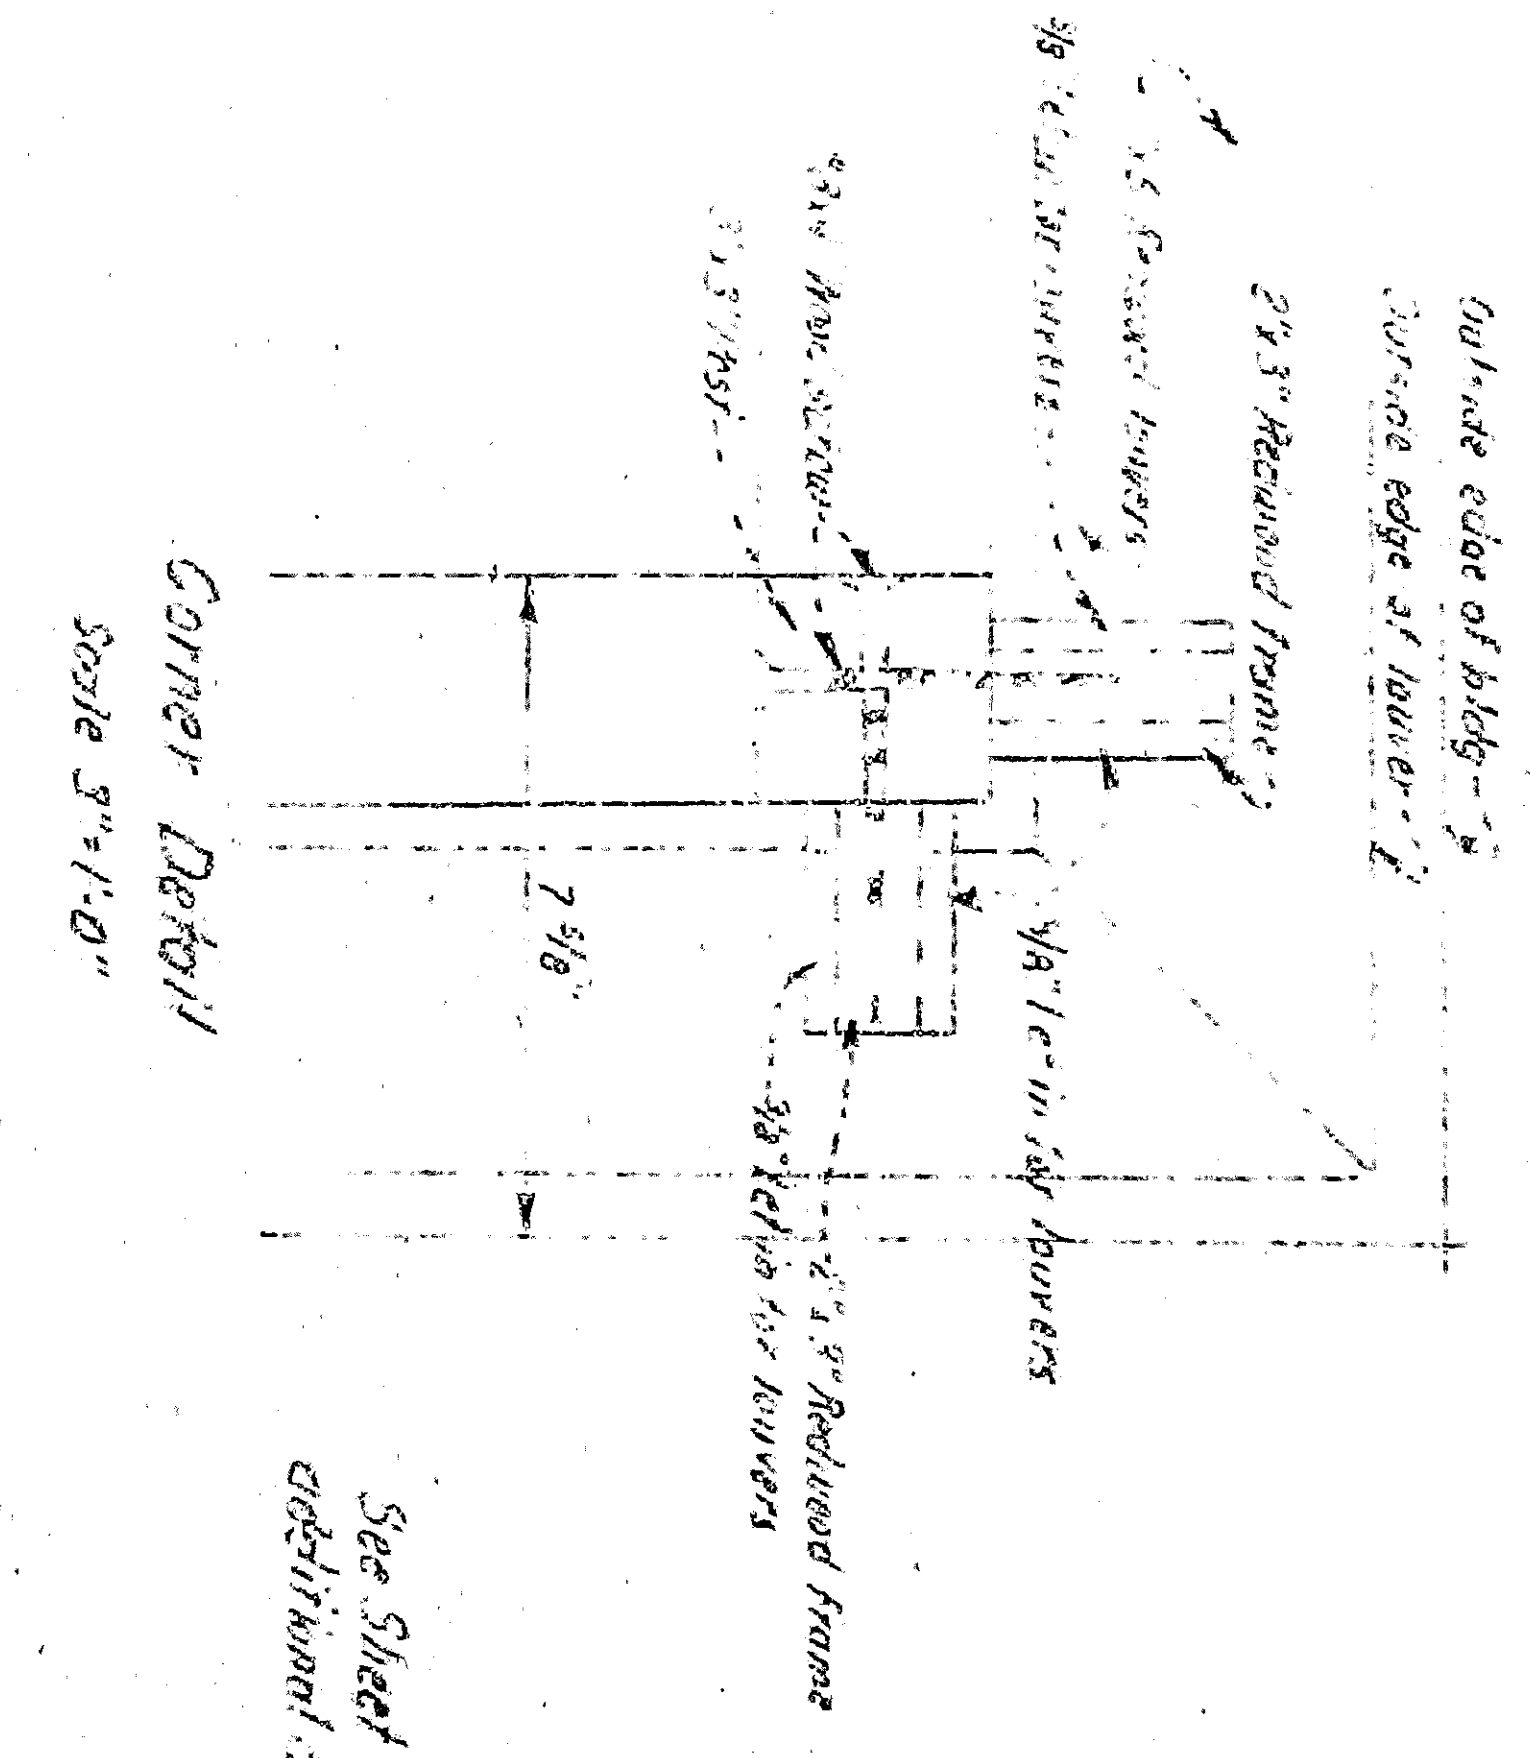

Section G-G  
Scale: 3/16" = 1'-0"

Section G-G  
Scale: 3/16" = 1'-0"

2613  
SHEET  
OF 20 SHEETS