



MEERS STREET SEWER - PLAN

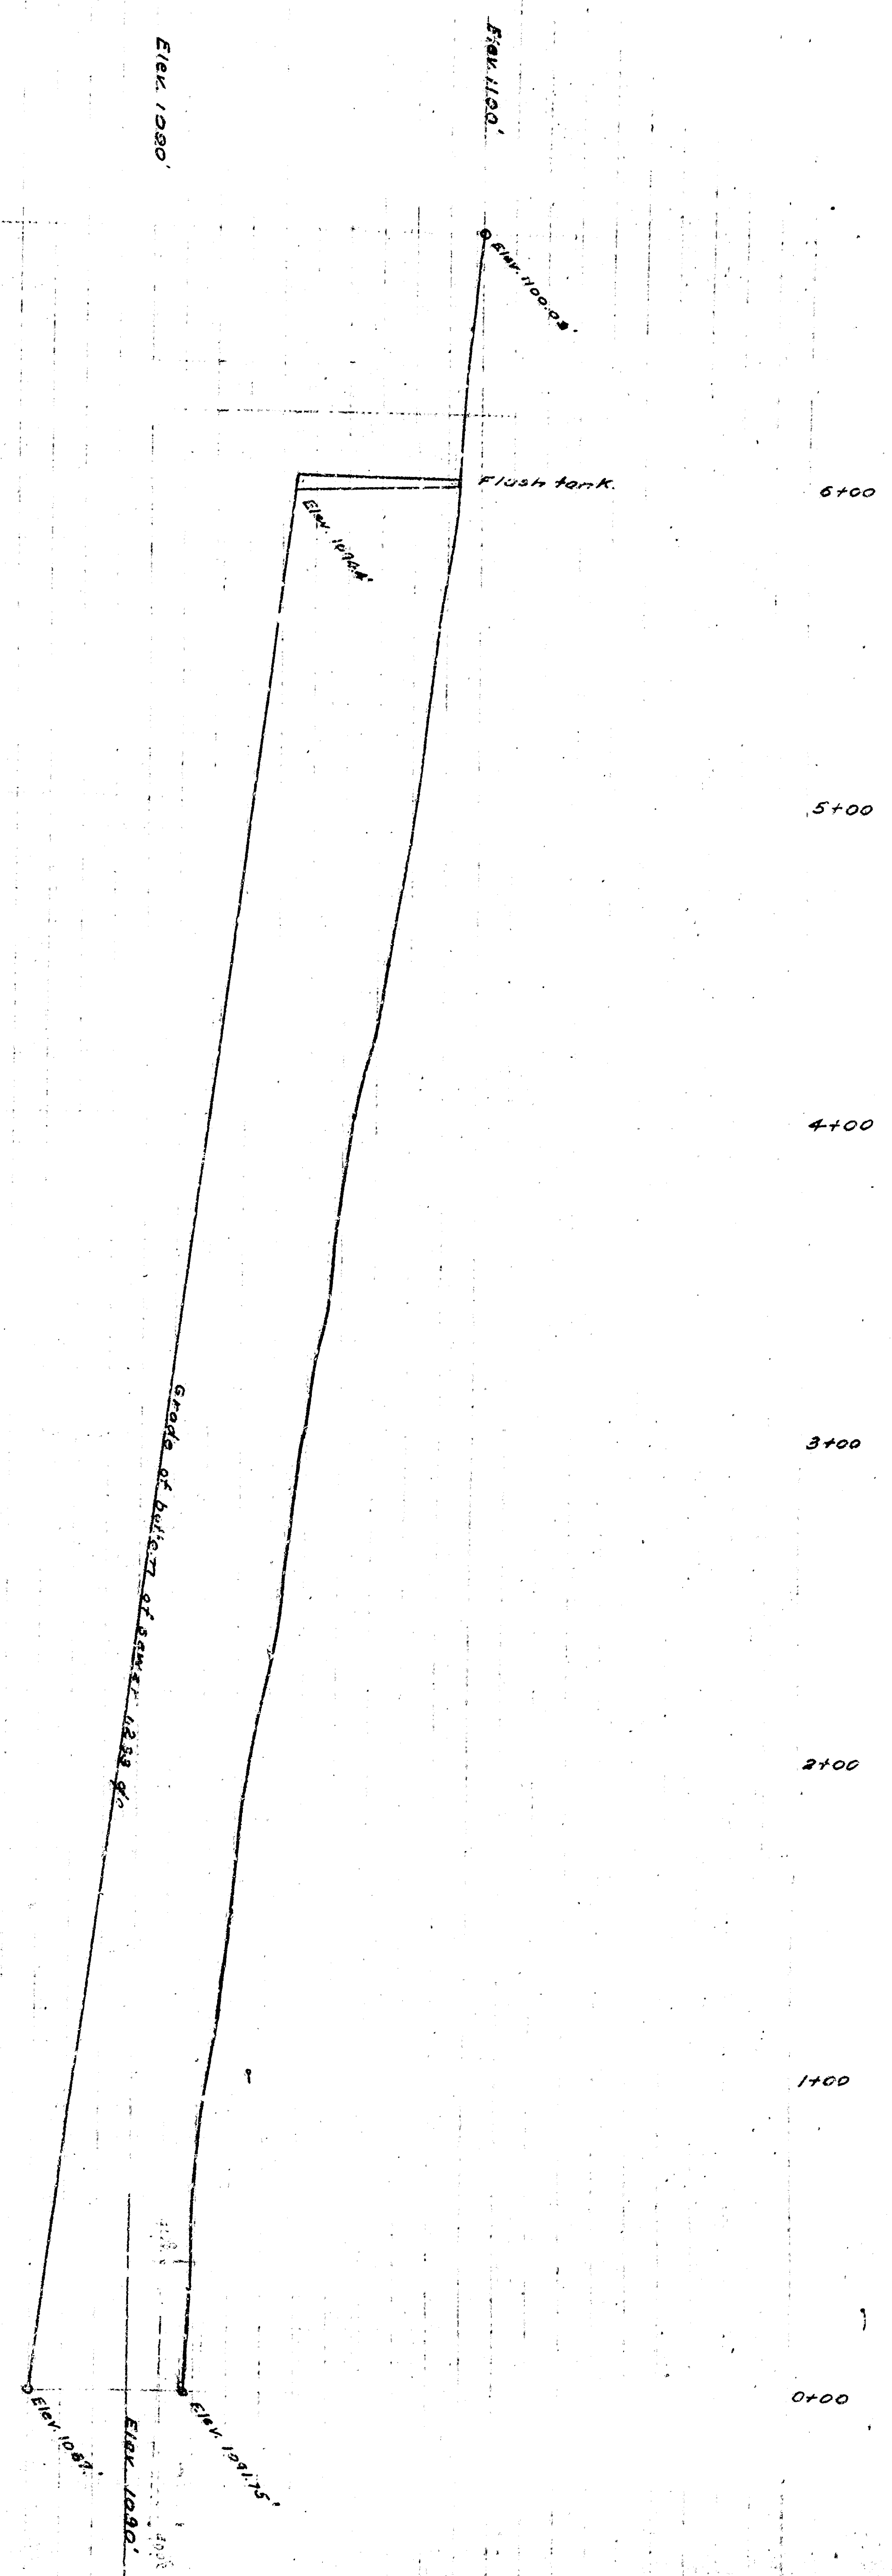


ESTIMATE OF QUANTITIES
 536 LINEAR FEET OF 6" SEWER INCLUDING WYES, (Vitrified pipe)
 432 LINEAR FEET OF 4" LATERAL SEWERS, (Vitrified pipe)
 16 - 6"x4" WYES
 16 - 4"x3/8" BENDS
 1 - FLUSH TANK
 1 - 6" - 1/2" BEND

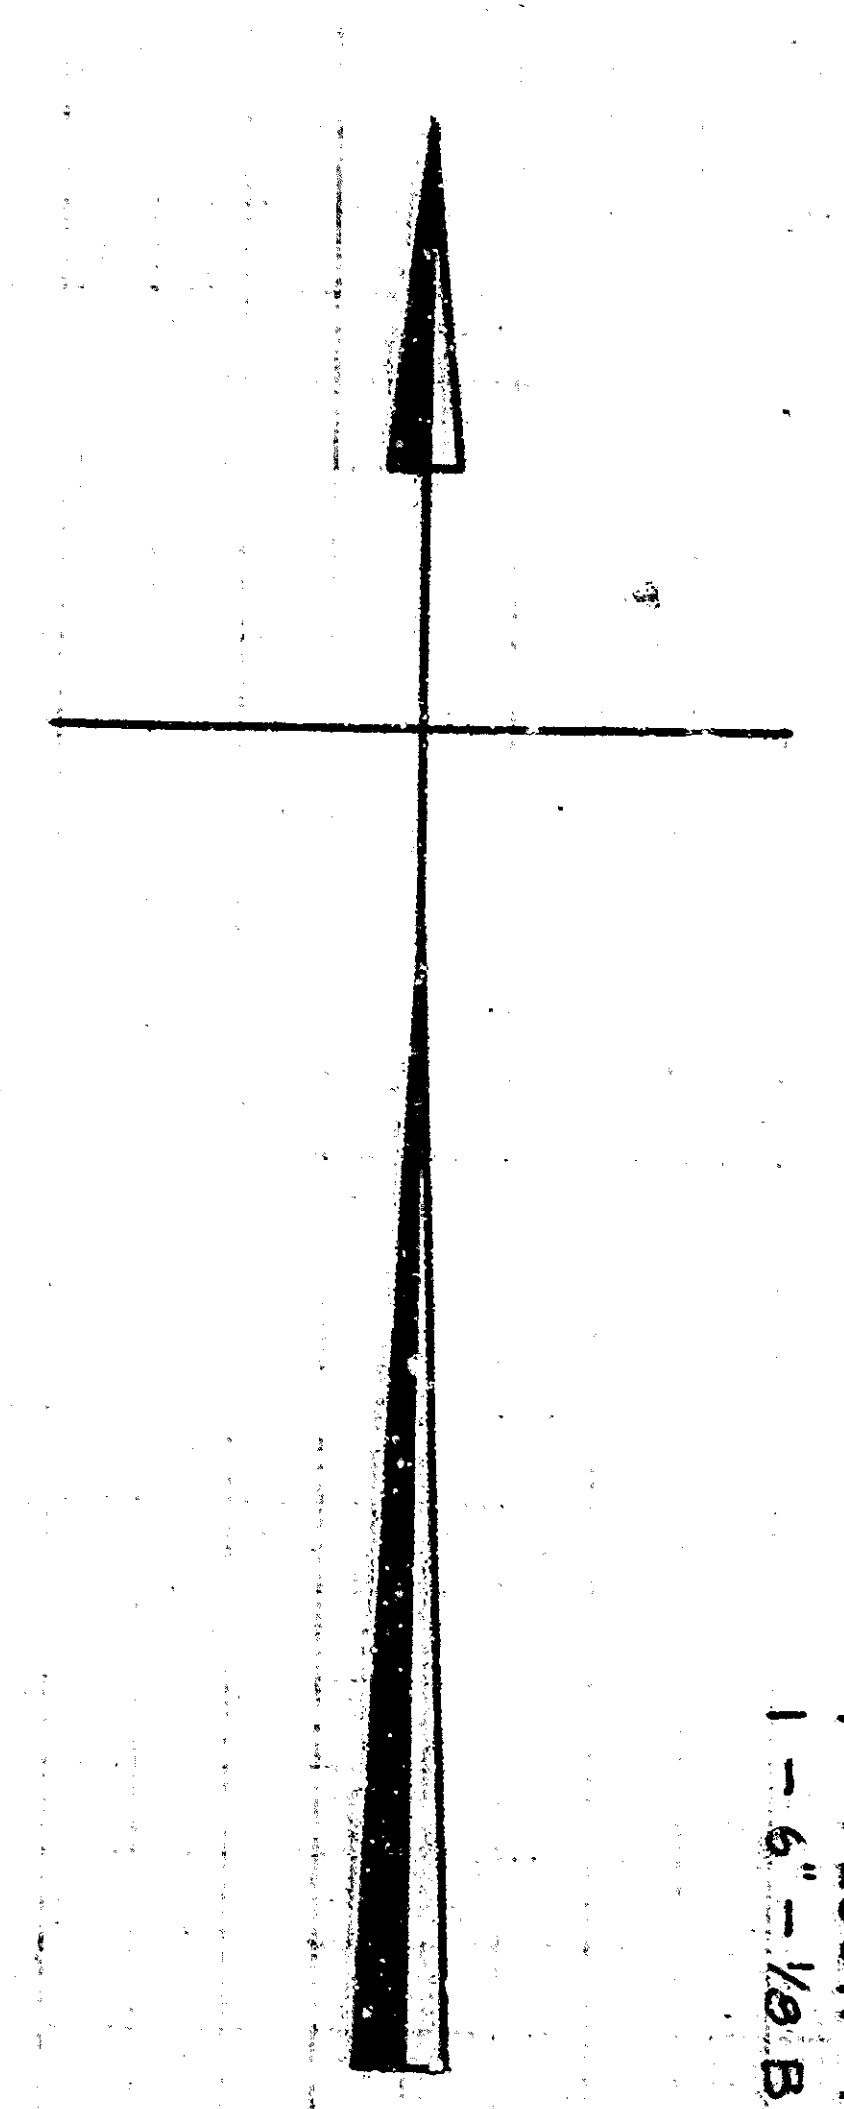

PLAN AND PROFILE
 OF
MYERS STREET
SEWER

A POINT 40 FEET SOUTH OF THE SOUTH
 CENTER LINE OF TENTH STREET TO THE
 CENTER LINE OF NINTH STREET
 SCALE (VERTICAL) 1" = 10' (HORIZONTAL) 1" = 100'

ABBREVIATIONS
 THE MARK (M) MEANS FEET OR FOOT
 THE MARK (N) MEANS INCH OR INCH
 NO. MEANS NUMBER
 RED LINE SHOWS CURB LINE
 BLACK DOTTED LINE SHOWS
 CENTER LINE OF SEWER
 THE LETTER 'a' designates a proposed pipe

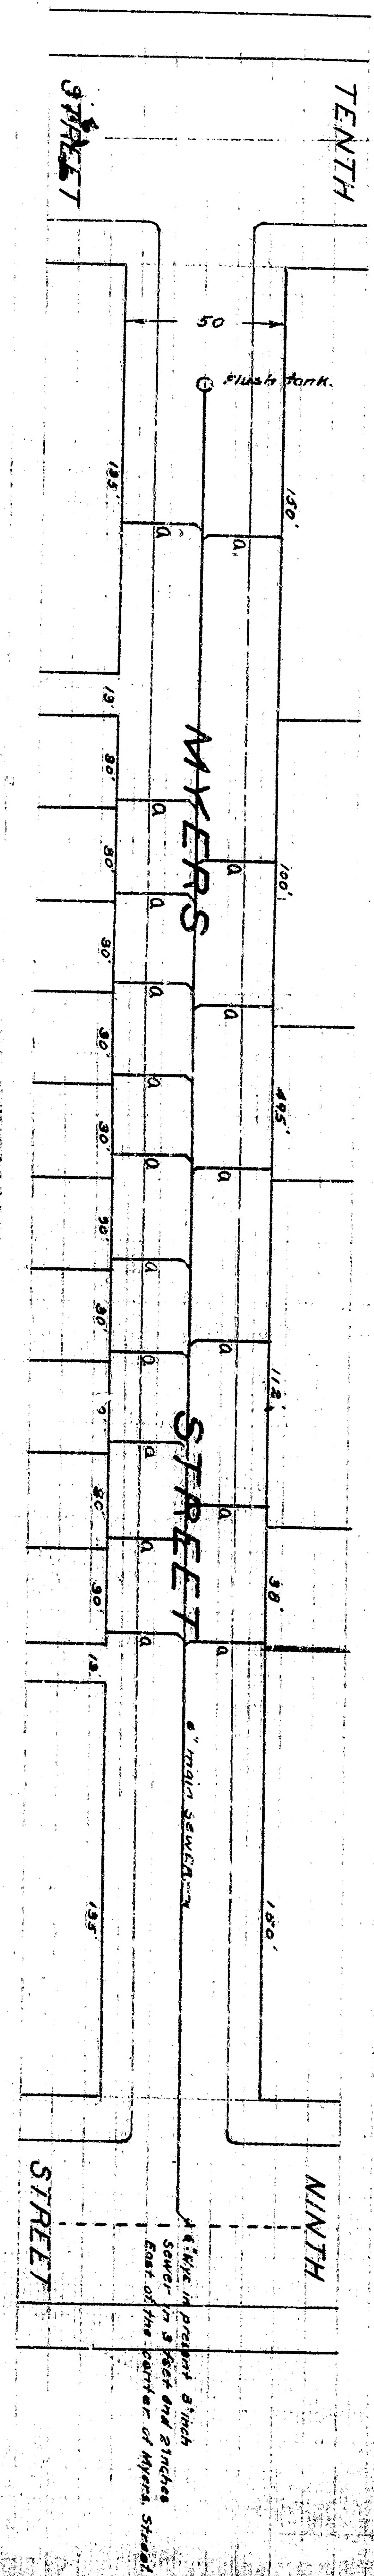

10th 4 1/2" x 10" x 10" x 10"